



Wisconsin Department of Transportation

August 9, 2024

**Division of Transportation Systems
Development**

Bureau of Project Development
4822 Madison Yards Way, 4th Floor South
Madison, WI 53705

Telephone: (608) 266-1631
Facsimile (FAX): (608) 266-8459

NOTICE TO ALL CONTRACTORS:

Proposal #09: 1130-44-74, WISC 2024402
Appleton – Green Bay
Wrightstown SWEF 34/Post-Bldg
IH 41
Outagamie County

Letting of August 13, 2024

This is Addendum No.02, which provides for the following:

Plan Sheets:

Revised Plan Sheets	
Plan Sheet	Plan Sheet Title (brief description of changes to sheet)
297	Revised piping detail
302	Revised mechanical room layout detail
311	Revised hot water system detail

The responsibility for notifying potential subcontractors and suppliers of these changes remains with the prime contractor.


Sincerely,

Mike Coleman

Proposal Development Specialist
Proposal Management Section


END OF ADDENDUM

① MECHANICAL KEYNOTES - M207
1 SPACE TEMPERATURE SENSORS FOR WARNING SYSTEM - RPT
2 SPACE TEMPERATURE SENSORS FOR WARNING SYSTEM - RPT
3 SPACE TEMPERATURE SENSORS FOR WARNING SYSTEM - RPT
100 SPACE TEMPERATURE SENSORS FOR WARNING SYSTEM - RPT

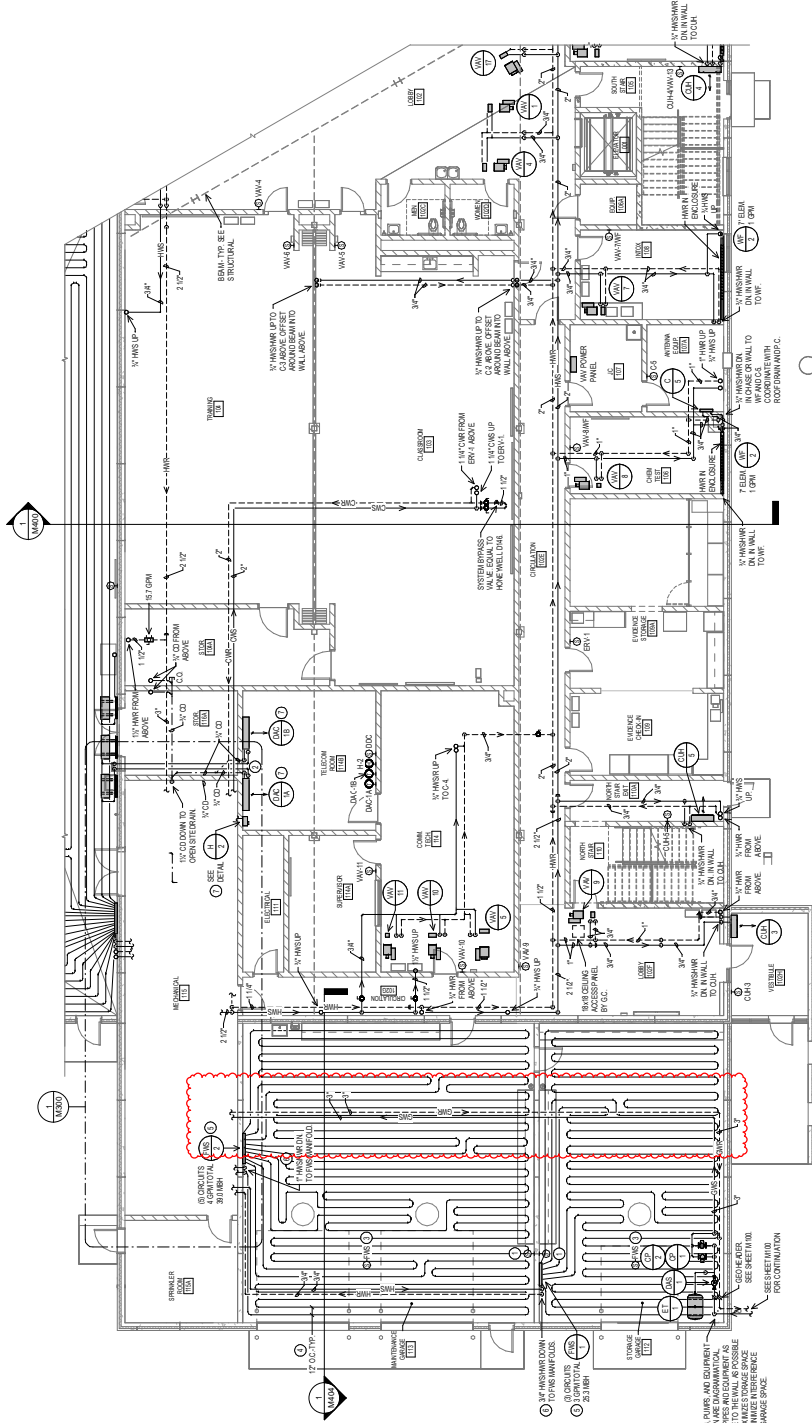

Addendum No. 02
ID 1130-44-74
Revised Sheet 297
August 9, 2024

1 MECHANICAL MAIN LEVEL FLOOR PLAN - AREA B
PIPING
M207
SCALE: 1/8" = 1'-0"
6 2 5 10

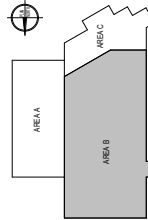


KEY PLAN

PLANS PREPARED BY: CBS SQUARED, INC., CHIPPEWA FALLS, WI	MECHANICAL MAIN LEVEL FLOOR PLAN - AREA B PIPING	DATE: 5/1/24	REVISION: FINAL
PROJECT NO: 1130-44-74	WRIGHTSTOWN SWEET & STATE PATROL POST FACILITY	DATE: M207	REVISION: 297
AUTODESK DOC: /KLE NC 2.1001 - SWEET/71107 MECH R21_mikebapvark.rvt	COUNTY: OUTAGAMIE	DATE: 8/8/2024 8:50:43 AM	

Addendum No. 02
ID 1130-44-74
Revised Sheet 302
August 9, 2024

MECHANICAL KEYNOTES - M300	
1	SEE DETAILS
2	DO NOT SCALE
3	DO NOT SCALE
4	DO NOT SCALE
100	DO NOT SCALE

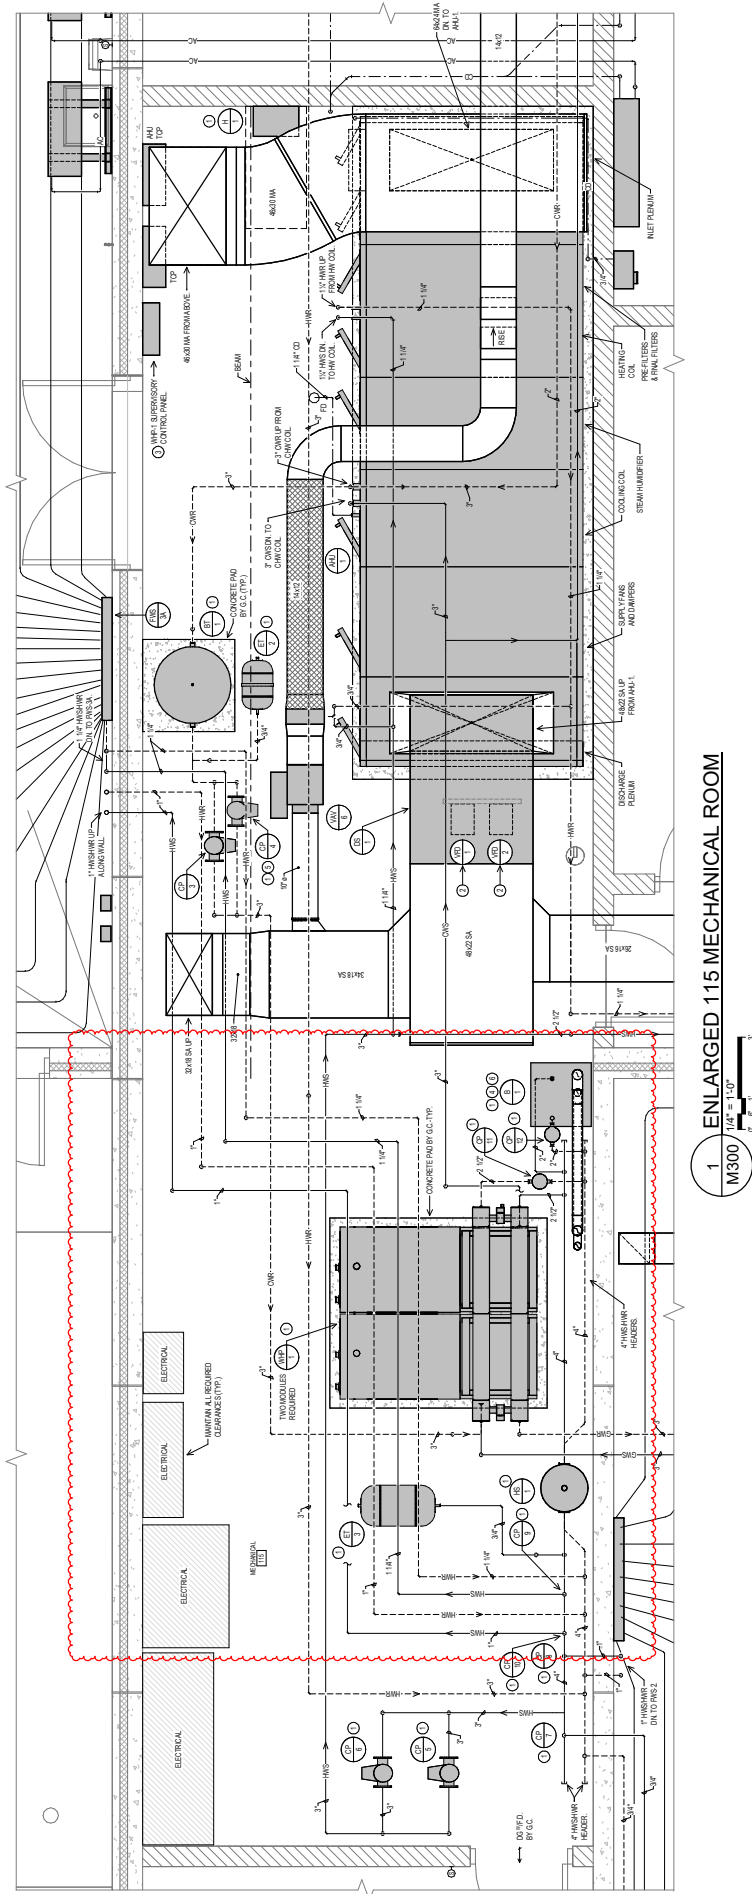

1 ENLARGED 115 MECHANICAL ROOM
M300
1/4" = 1'-0"

PLANS PREPARED BY: CBS SQUARED, INC., CHIPPEWA FALLS, WI	ENLARGED 115 MECHANICAL ROOM	DATE: 5/1/24	FINAL
PROJECT NO: 1130-44-74	WRIGHTSTOWN SWEET & STATE PATROL POST FACILITY	DATE: M300	302
AUTODESK DOC: KLE NC 2.1001 - SWEET/1107 MECH R21_mikebapvnr.rvt	COUNTY: OUTAGAMIE	DATE: 8/8/2024 8:50:44 AM	
	HWY: IH 41		

